


LIGHTING PLAN

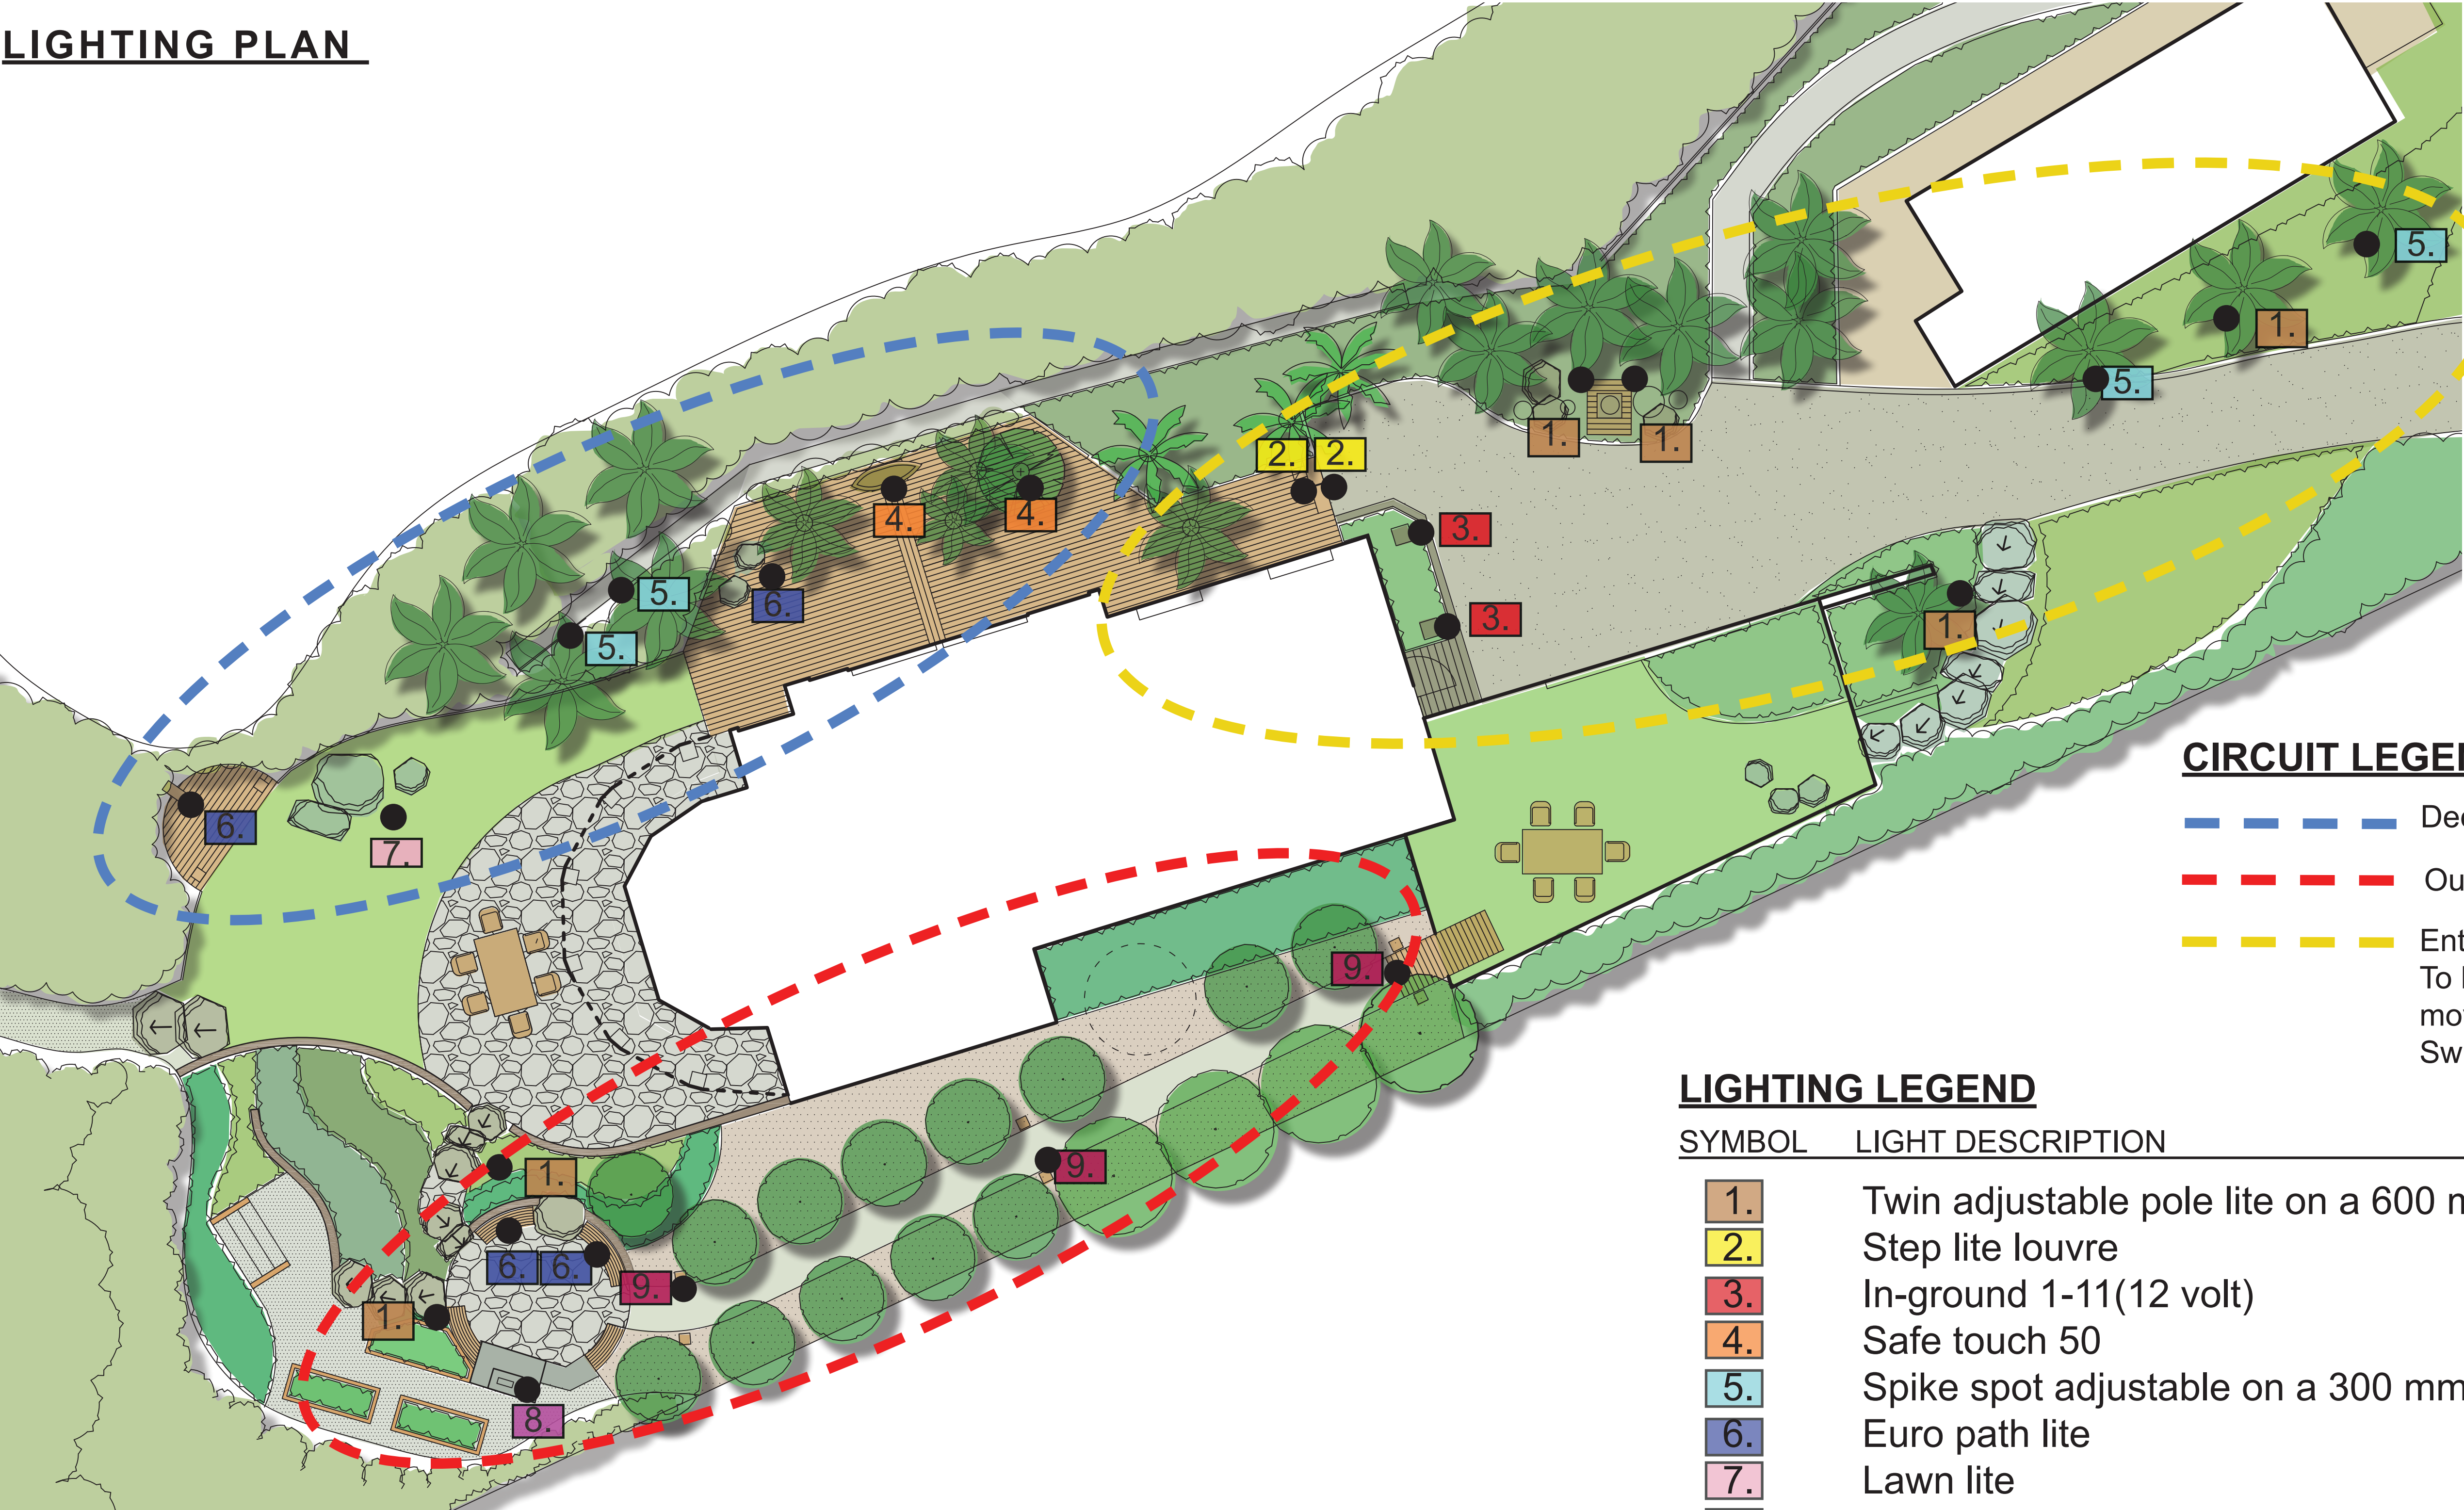

CIRCUIT LEGEND

- Deck Area
- Outdoor Fire & Orchard
- Entrance Area -  
To be on automatic sensor for any  
movemnet in driveway area.  
Switch by front door.


LIGHTING LEGEND

SYMBOL	LIGHT DESCRIPTION	NUMBER
1.	Twin adjustable pole lite on a 600 mm stand	6
2.	Step lite louvre	2
3.	In-ground 1-11(12 volt)	2
4.	Safe touch 50	2
5.	Spike spot adjustable on a 300 mm stand	4
6.	Euro path lite	4
7.	Lawn lite	1
8.	Single wall spot	1
9.	Mouse lite	3


LIGHTING PALETTE



1. Twin pole 2. Step lite louvre 3. In-ground 1-11(12 volt) 4. Safe touch 50 5. Spike spot 6. Euro path lite 7. Lawn lite 8. Single wall spot 9. Mouse lite

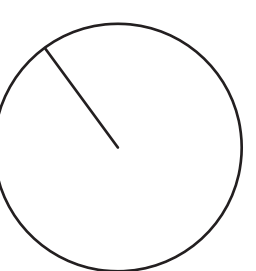

PROJECT:	Krauer Residence
	Kent Terrace
	Riverhead
DRAWING:	LIGHTING PLAN
DATE:	30 MARCH 2012
SCALE:	1:100 @A1   1:200@A3
DRAWN:	V.Anderson



**Shuter Design Co.**  
PH 0226-820-283.  
28 Hone Heke Rd,  
Kerikeri,  
Northland.